



REVISIONS	BY

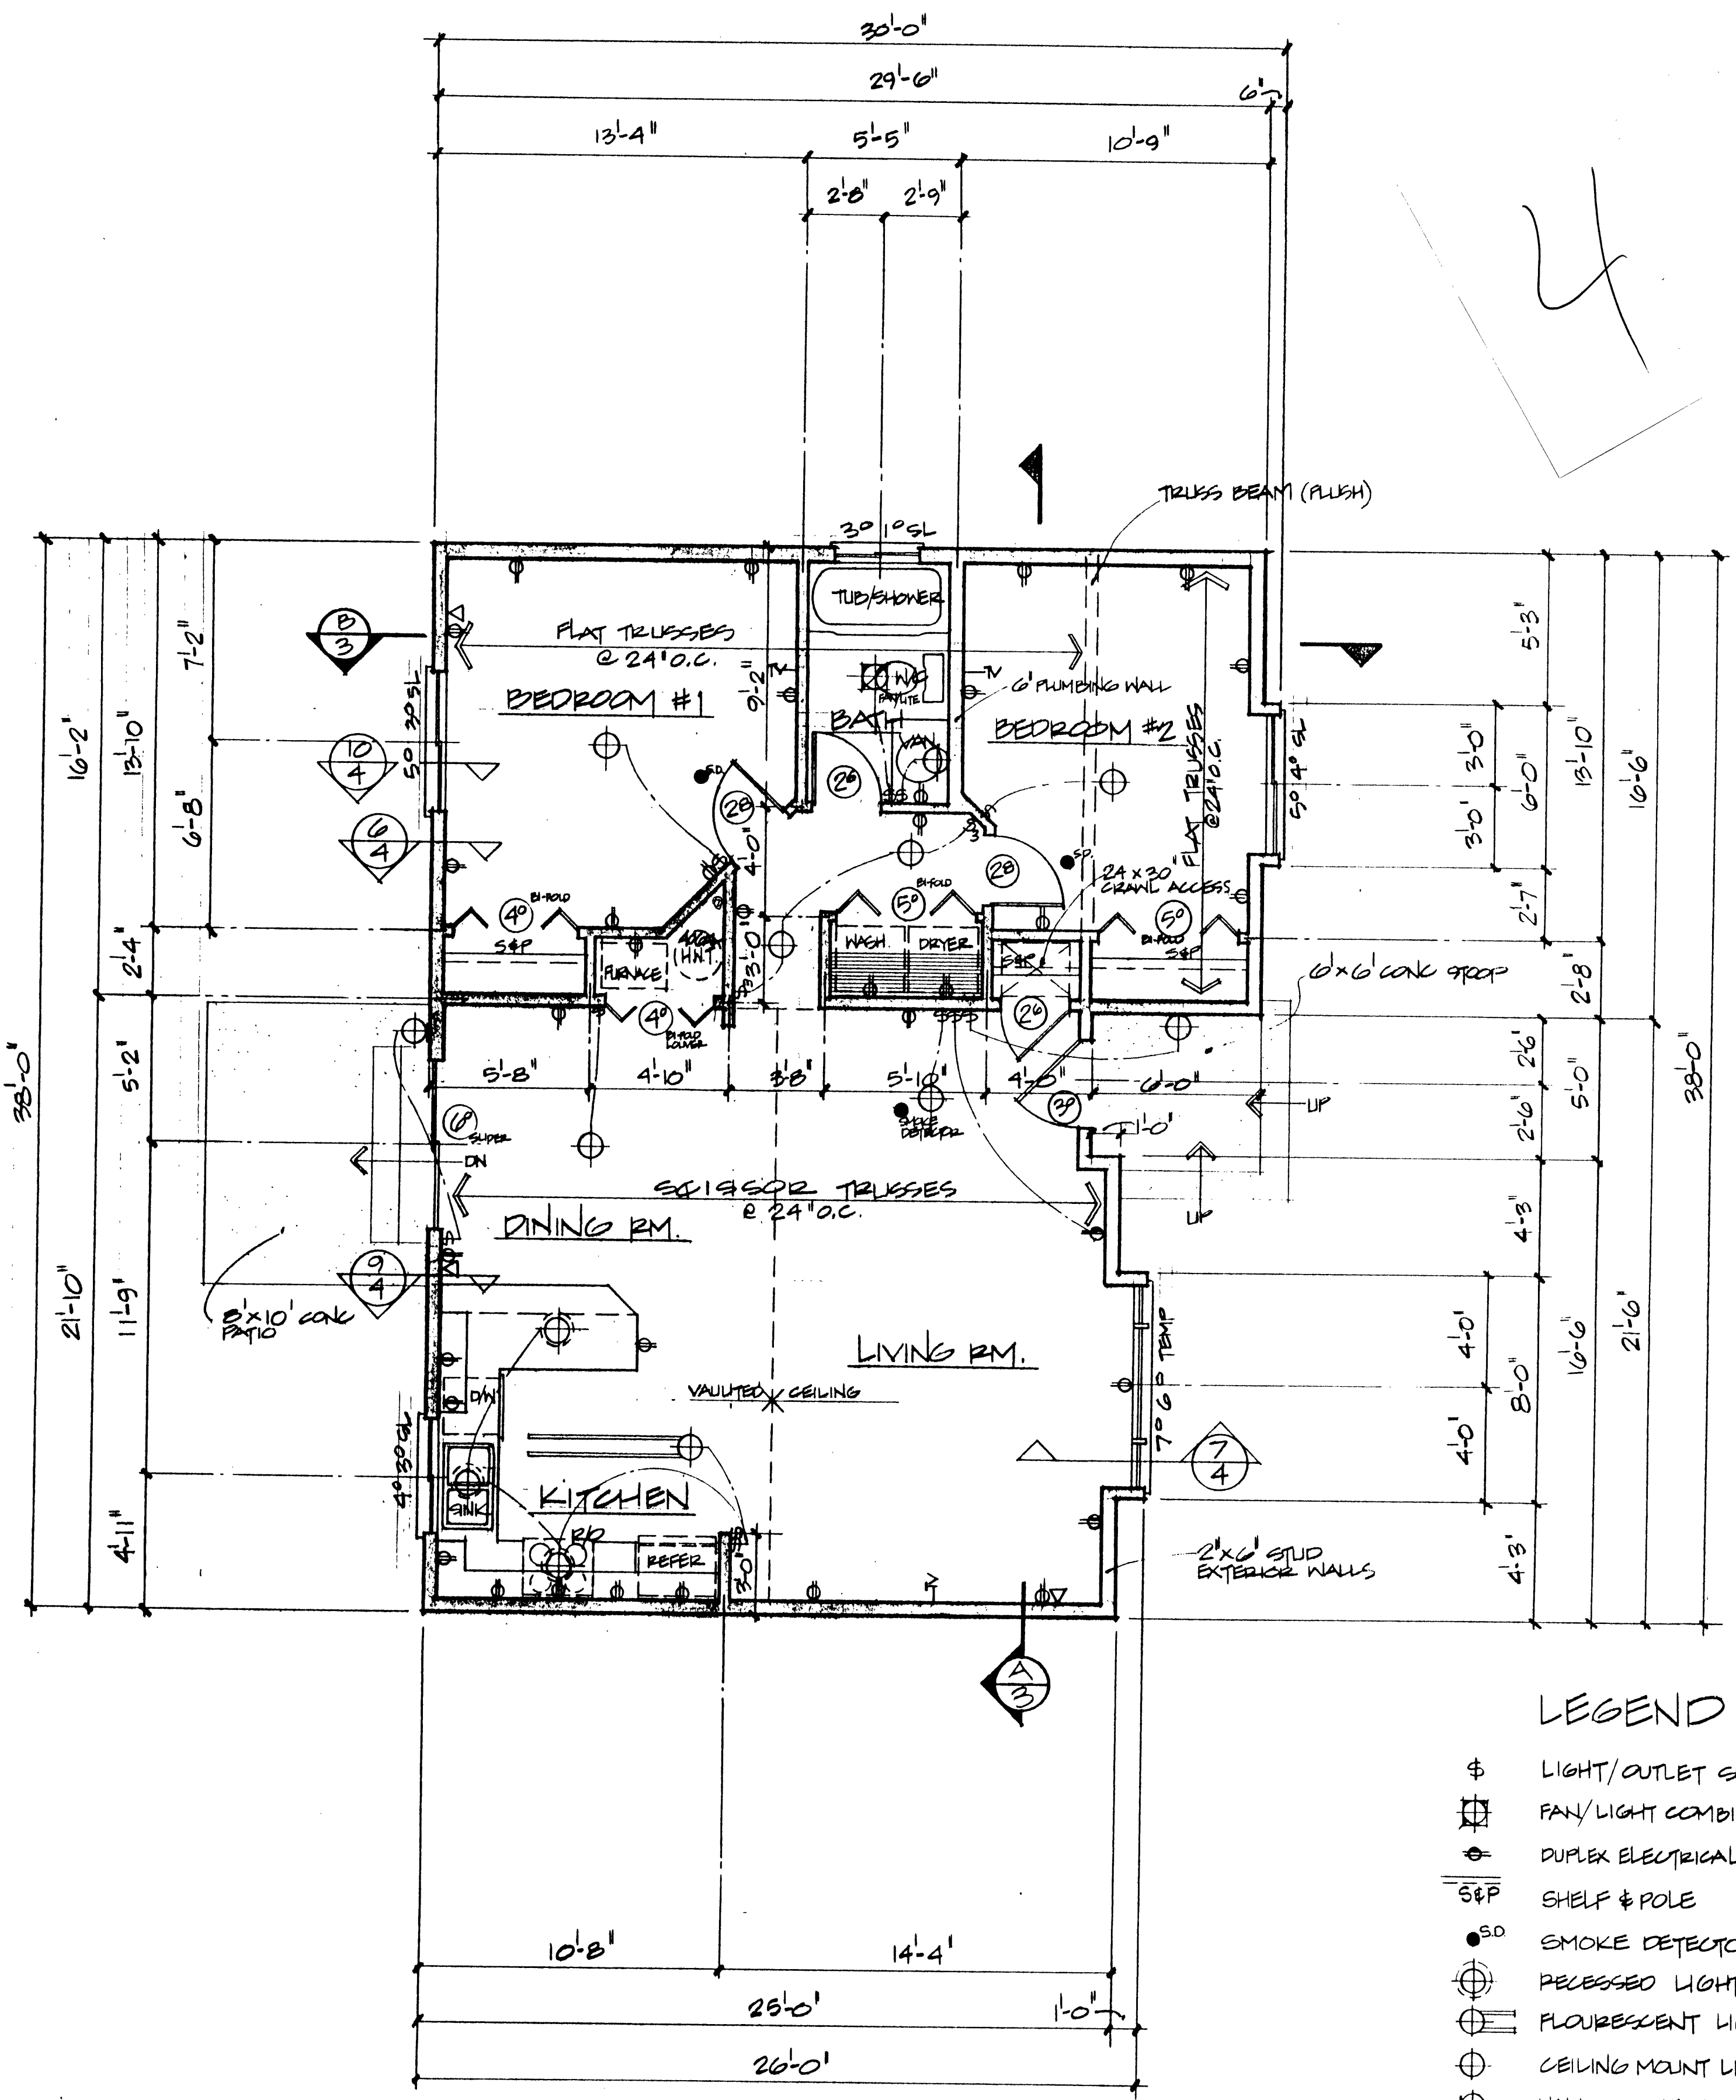

MAIN FLOOR PLAN
1/4" = 1'-0"

- LEGEND
- ⊕ LIGHT/OUTLET SWITCH
 - ⊞ FAN/LIGHT COMBINATION
 - ⊕ DUPLEX ELECTRICAL OUTLET - SPLIT WIRED
 - S&P SHELF & POLE
 - ⊙ SMOKE DETECTOR
 - ⊕ RECESSED LIGHT FIXTURE
 - ⊕ FLUORESCENT LIGHT FIXTURE
 - ⊕ CEILING MOUNT LIGHT FIXTURE
 - ⊕ WALL MOUNT LIGHT FIXTURE
 - ⊕ DUPLEX ELECTRICAL OUTLET
 - ⊕ 220V ELECTRICAL OUTLET
 - T-V CABLE OUTLET
 - K TELEPHONE JACK
 - CONCRETE

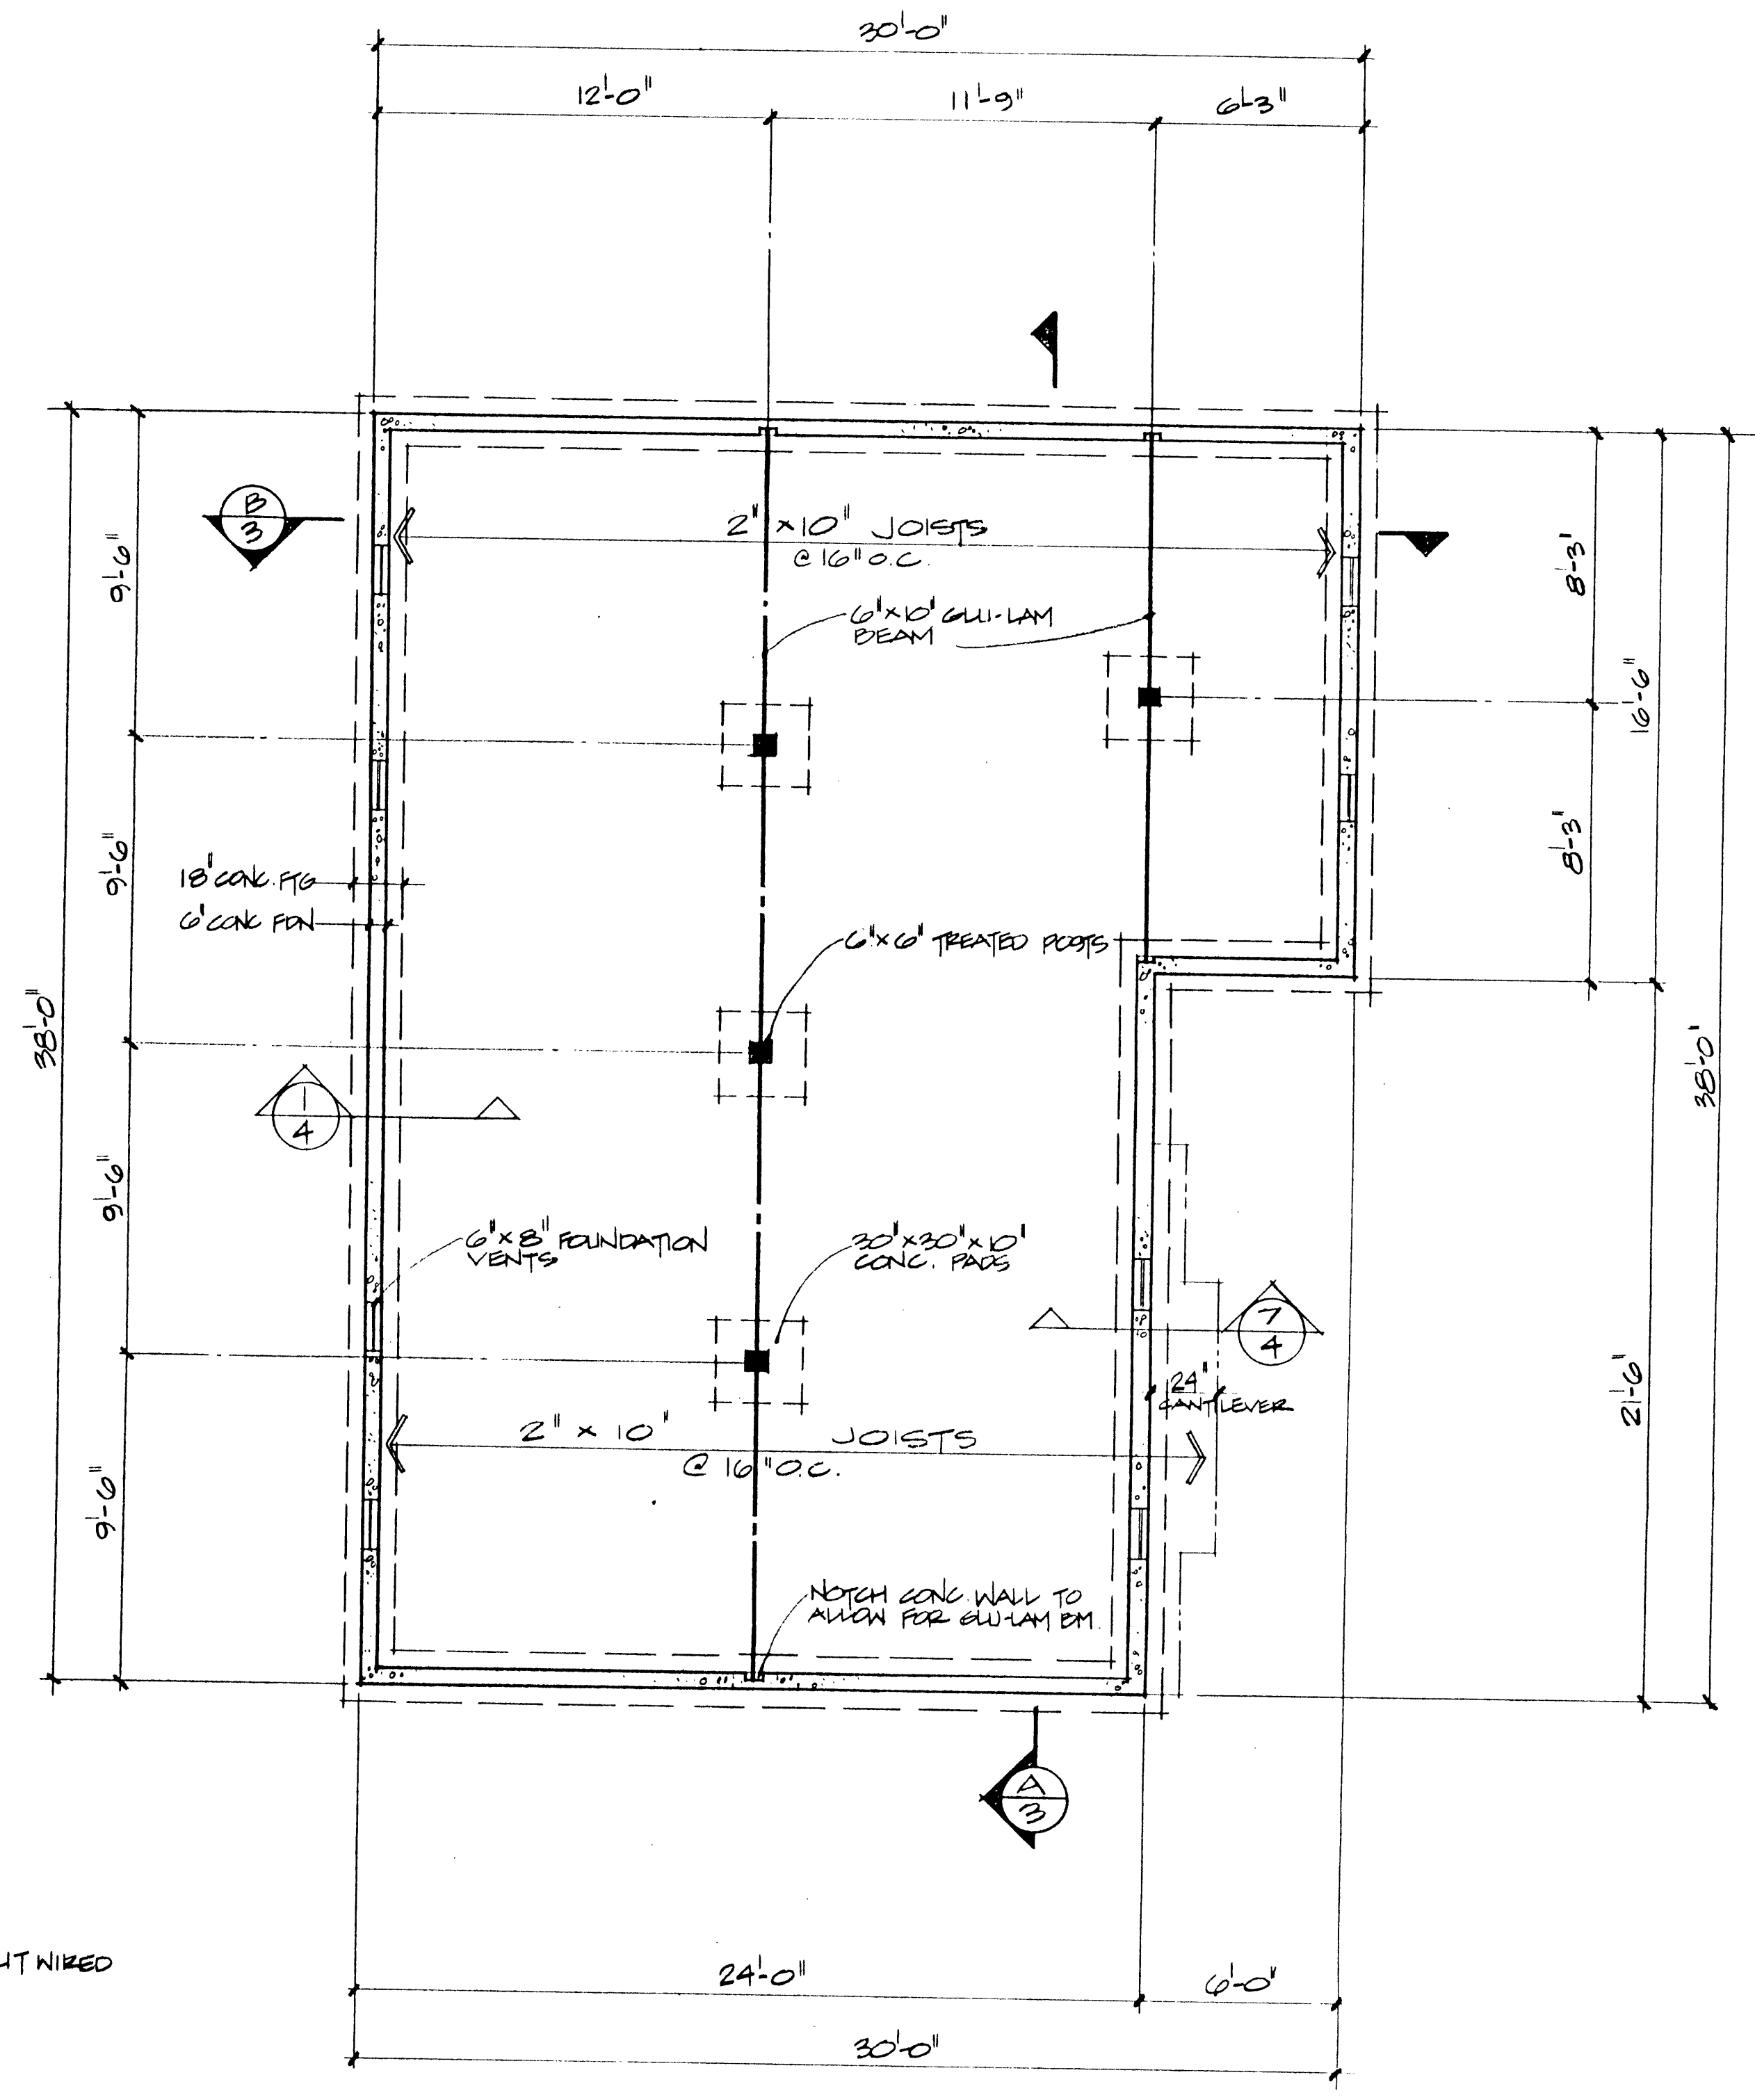

FOUNDATION PLAN
1/4" = 1'-0"

Spokane Indian Housing Authority
 Mutual Help Development Projects WA 37-12, WA 37-13, WA 37-14
 Project Manager: CMA Project Management, Inc. Architect: Designamics

DRAWN
D. GEORGE
 SQUARE FT.
1014
 DATE
AUG 8, 1995
 SCALE
1/4" = 1'-0"
 PLAN NO.
1014-B
 SHEET
2
 OF SHEETS